


FIRST ANGLE PROJECTION

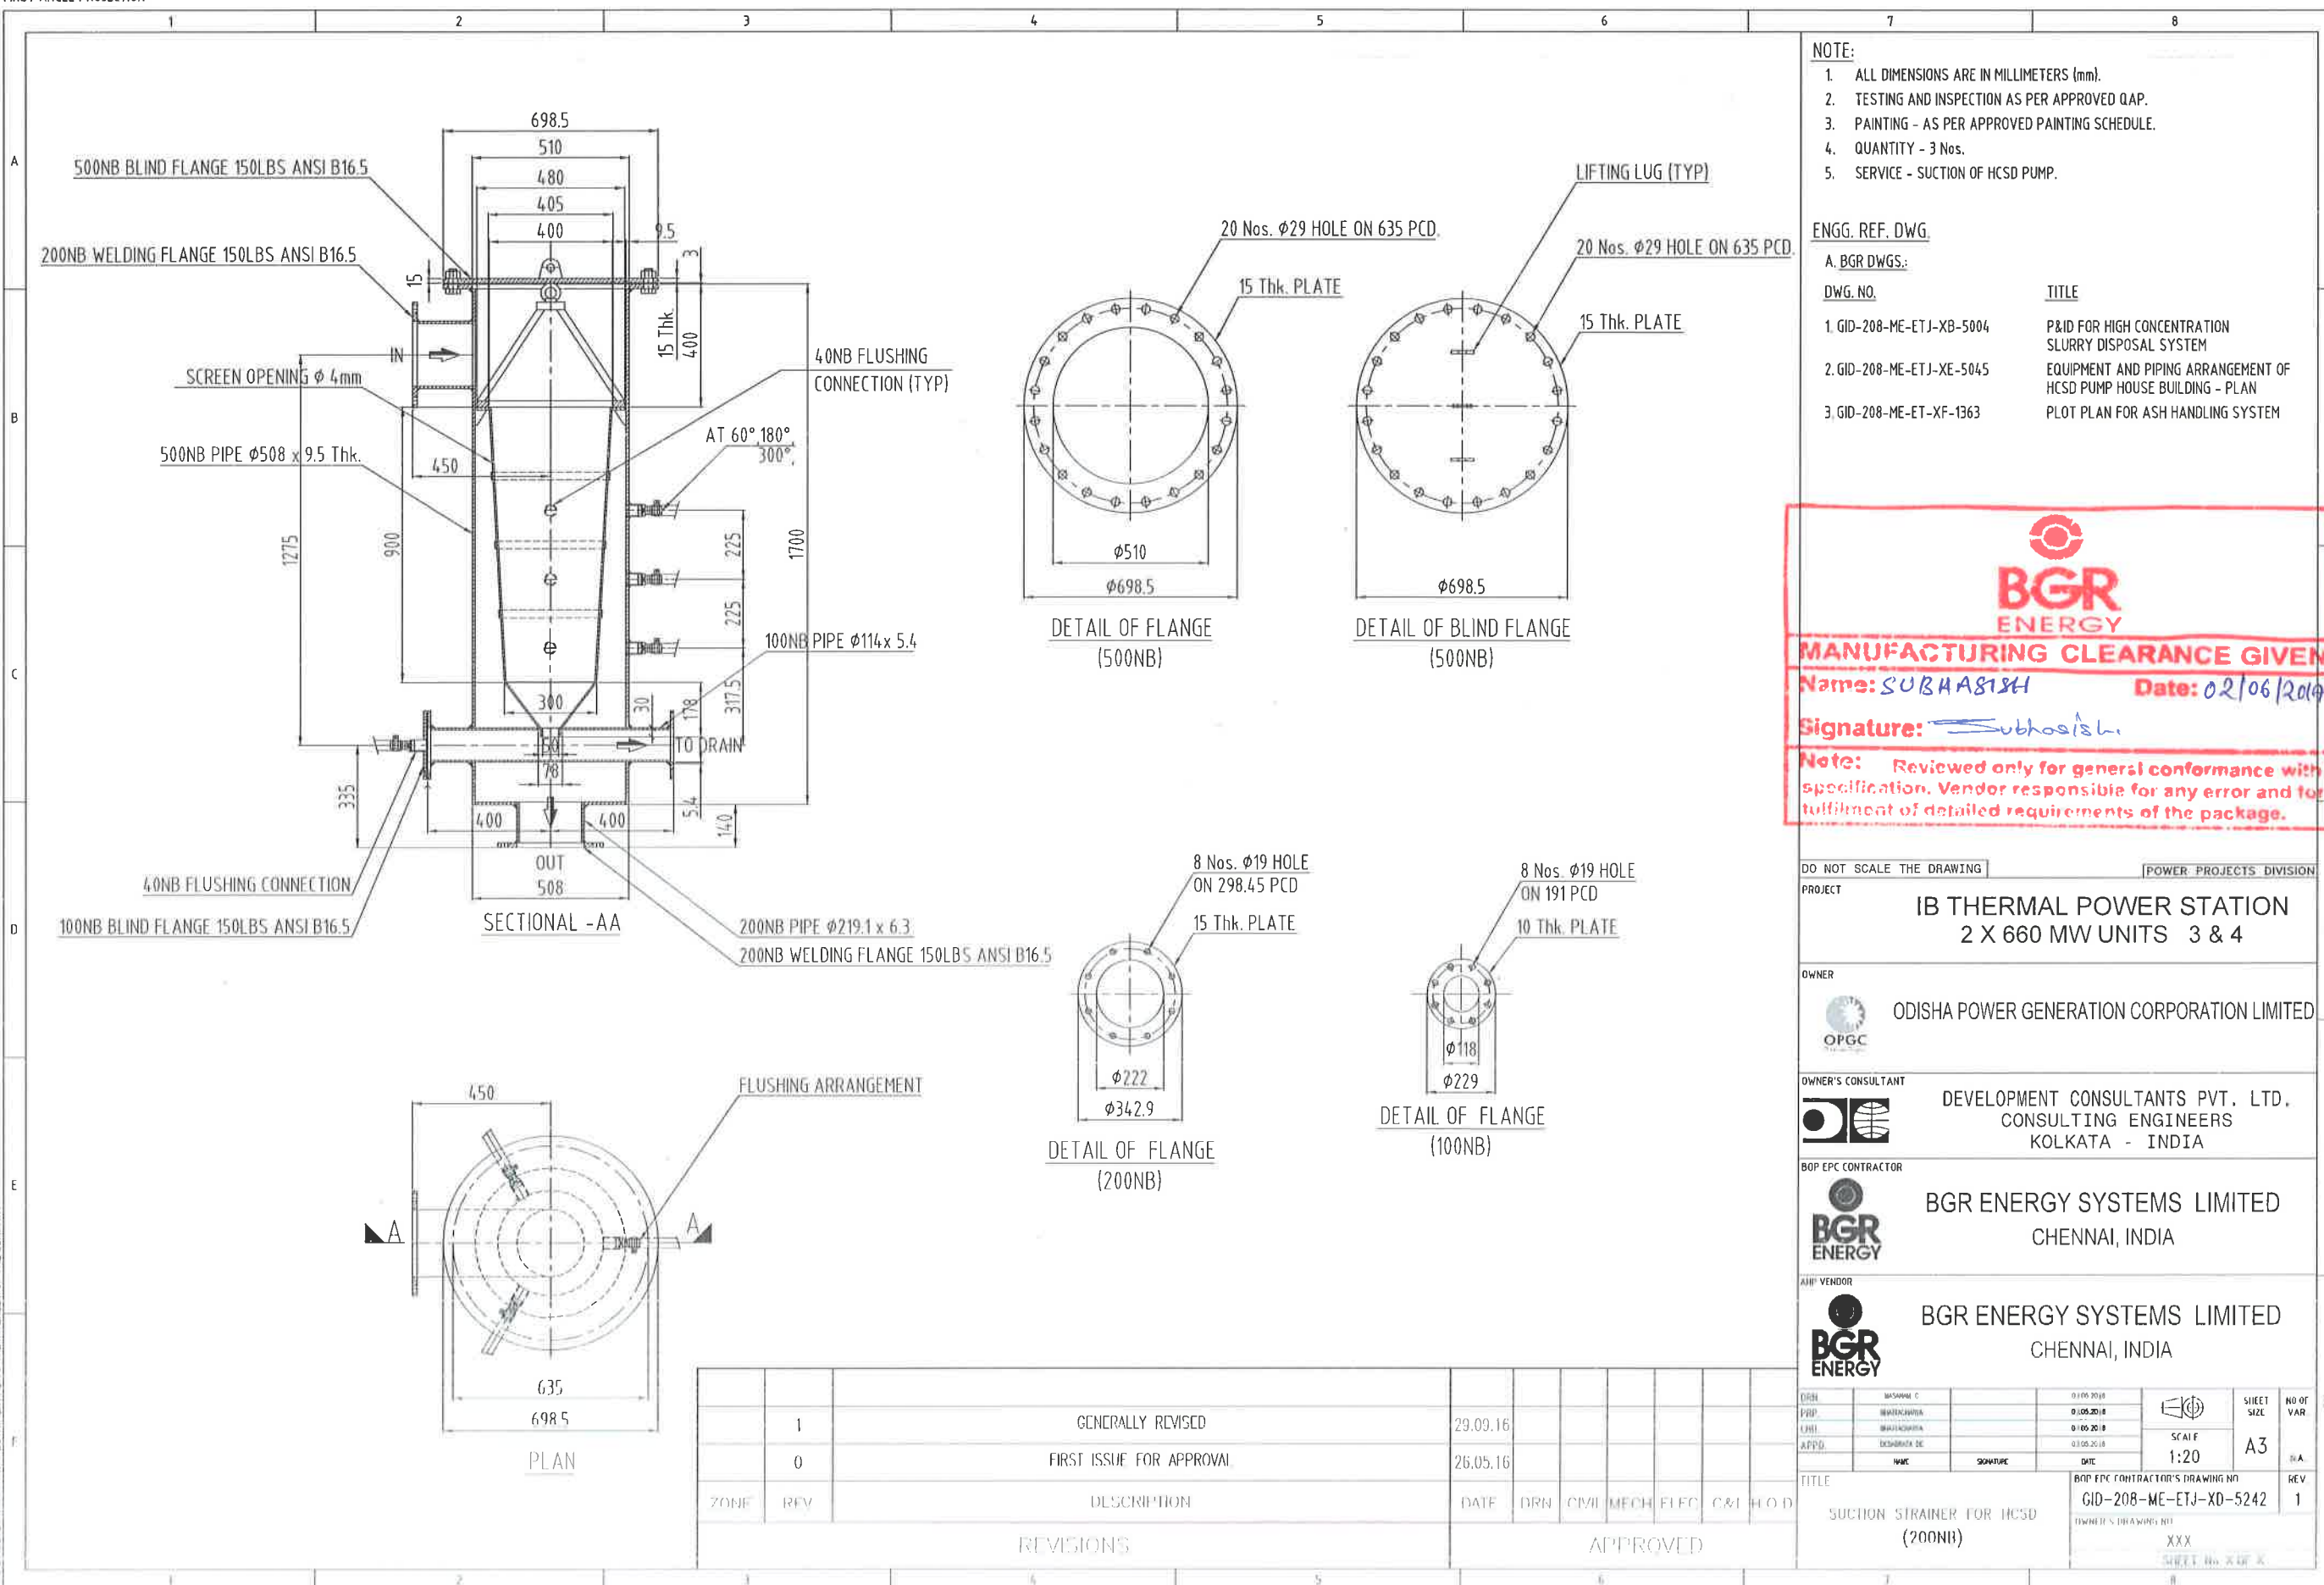

NOTE:

1. ALL DIMENSIONS ARE IN MILLIMETERS (mm).
2. TESTING AND INSPECTION AS PER APPROVED QAP.
3. PAINTING - AS PER APPROVED PAINTING SCHEDULE.
4. QUANTITY - 3 Nos.
5. SERVICE - SUCTION OF HCSD PUMP.

ENGG. REF. DWG.

A. BGR DWGS:

DWG. NO.

1. GID-208-ME-ETJ-XB-5004
2. GID-208-ME-ETJ-XE-5045
3. GID-208-ME-ET-XF-1363

TITLE

P&ID FOR HIGH CONCENTRATION
SLURRY DISPOSAL SYSTEM
EQUIPMENT AND PIPING ARRANGEMENT OF
HCSD PUMP HOUSE BUILDING - PLAN
PLOT PLAN FOR ASH HANDLING SYSTEM



MANUFACTURING CLEARANCE GIVEN

Name: SUBHASISH

Date: 02/06/2016

Signature: Subhasish

Note: Reviewed only for general conformance with
specification. Vendor responsible for any error and for
fulfilment of detailed requirements of the package.